


BOLLARD LAMPS LINKED TO PIR'S

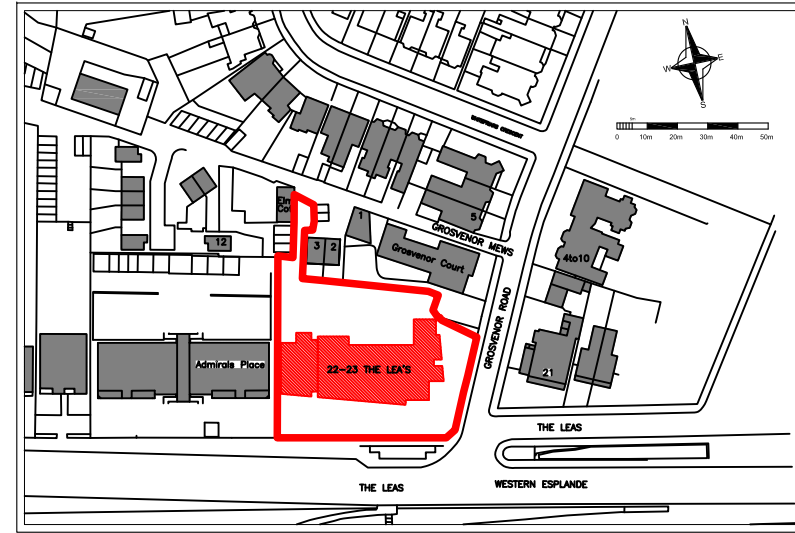

SITE PLAN
1:2500 @A3



Copyright of this drawing belongs to & is vested in **THIRDWAY INTERIORS** and may not be reproduced or without written consent by **THIRDWAY INTERIORS**. Any persons, firm or company unlawfully reproducing or distributing this drawing or in any way infringing the copyright therein will be prosecuted.

This document is the property of **THIRDWAY INTERIORS**. Copyright is reserved by them, and the drawing is issued on the condition that it is not copied, reproduced or retained by, nor disclosed to any unauthorised person, either wholly or in part, without the consent in writing from **THIRDWAY INTERIORS**.

Drawing Approval

Client Signature	
Printed Name	
ThirdWay Signature	
Date	
Specification Ref	

Status

- Preliminary/Info.
- Contract
- Planning
- Construction
- As-Built
- Building Control

Revision Detail

Rev	Detail	By	Date

PLANNING DRAWING

Client	THE SHORE
--------	-----------

Project Title	22-23 THE LEAS WESTCLIFF-ON-SEA ESSEX SS0 8FF
---------------	--

Drawing Title	LANDSCAPING LIGHTING PLAN PLANNING DRAWING
---------------	--

Date: 17.02.16	Drawn By: DJ
----------------	--------------

Scale: 1:150@A3	Rev: A
-----------------	--------

Drawing No: TWI-1250-AF-D350
