 


PROPOSED GROUND FLOOR PLAN  
Scale 1:100




Indicative mechanical ventilation extract position on roof

Center section of solar panels raised 1200mm above roof level above plant extract

CARBON FILTER UNIT - 1300h X 2000w X 1500l, FILTERS TO HAVE 3 STAGE FILTRATION MESH FILTERS, BAG FILTERS, CARBON FILTERS

630JM THREE PHASE FAN, 72Dba BREAKOUT, 2 SILENCERS FITTED WILL REDUCE TO 48Dba

A	21.07.16	PLANNING SUBMISSION
Rev.	Date:	Amendment:

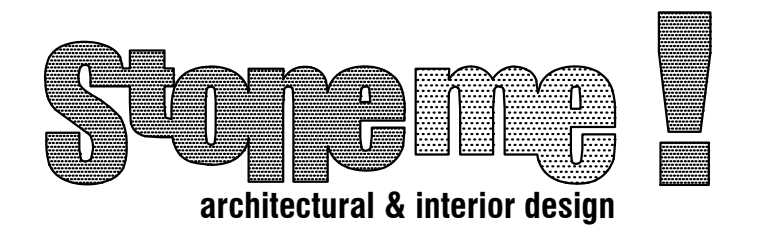

The Studio, 8 The Canters, Thundersley, Benfleet, Essex. SS7 3DJ  
Tel: 01702 555411 / Fax: 01702 555411  
E: info@stoneme.com W: www.stoneme.com

Client: MR M NORCROSS

Project: THE GRAND HOTEL  
LEIGH-ON-SEA  
ESSEX

Drawing: PROPOSED ROOF PLAN /  
EXTRACT FILTERS

Date: 16.11.2015 Scale: 1:100 @ A1

Project No.: Drawing No.: