
 
 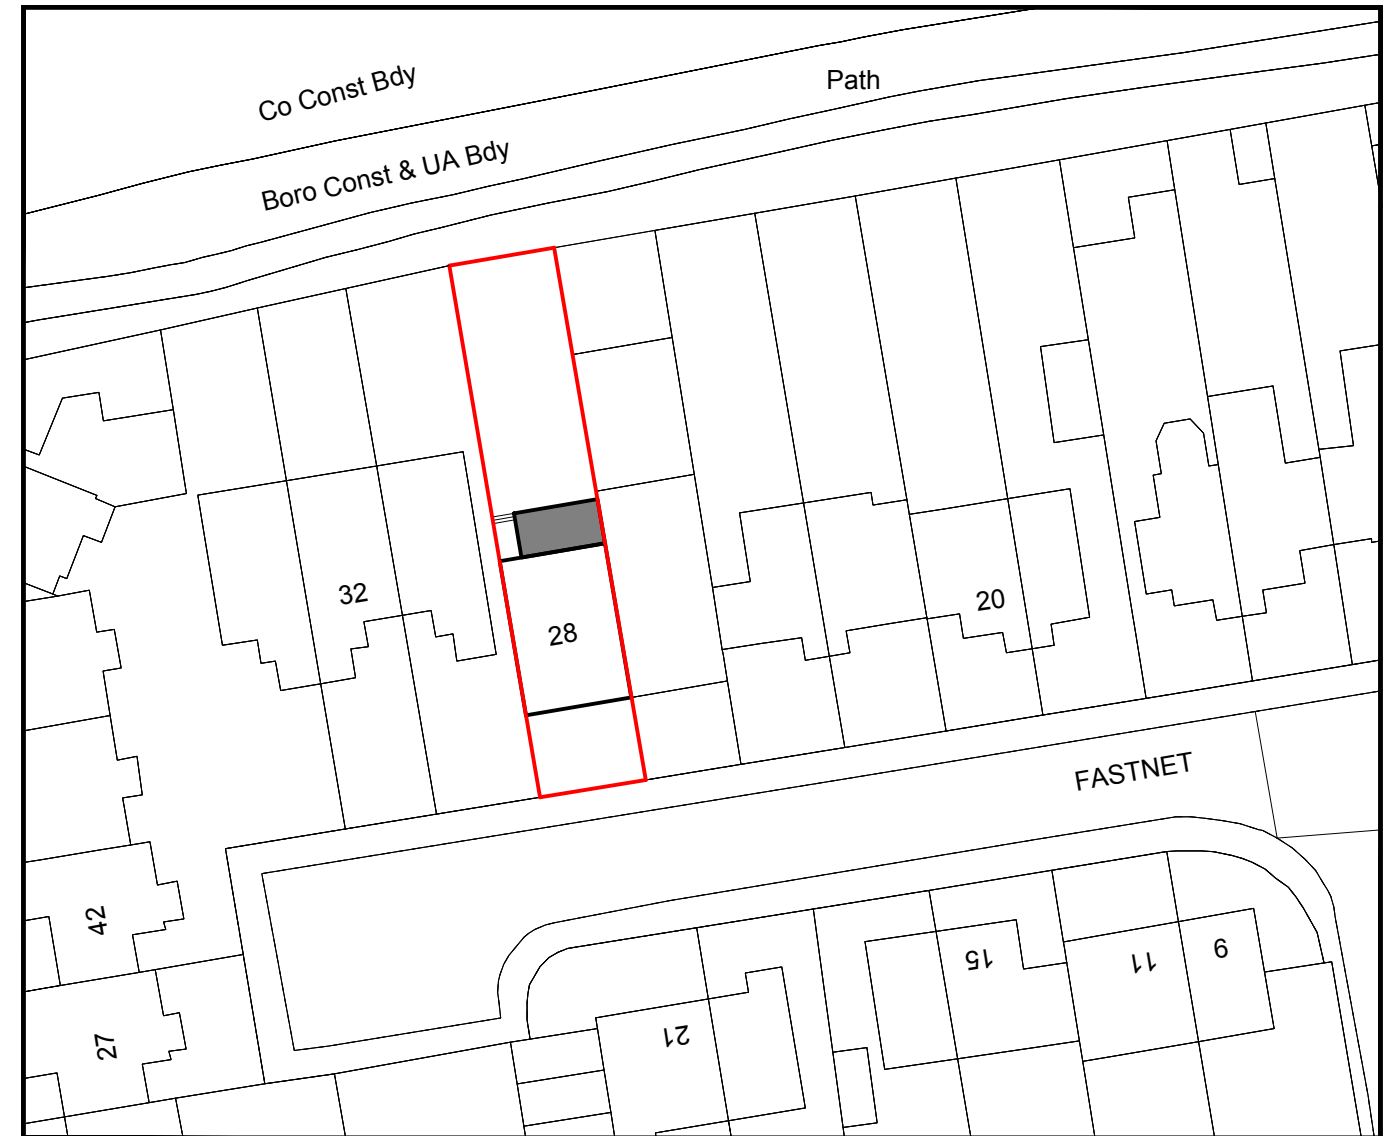
 


Existing Block Plan
Scale 1:500



 
Proposed Block Plan
Scale 1:500



Revision notes:		
Rev:	Date:	Notes:
001		<p>The Contractor must carry out His/Her own measured survey prior to works commencing on site to verify site dimensions and to report any discrepancies to the Designer. Contractor to refer to Building Control Notes. Contractor is responsible for final on site design using on site dimensions.</p> <p>Contractor responsible for on site drainage layout/runs - to be agreed by Building Control prior to Construction starting on site. All Details to be approved by Building Control prior to construction starting on site.</p>

Drawn by: FD	Project: 28 Fastnet, SS2 6TX
Client:	Drawing Title: EXISTING BLOCK PLAN PROPOSED BLOCK PLAN

Date: 13.08.2021	No.: 21-0656
Scale @ A3: 1:500	Rev: E
Issue: PLANNING DRAWINGS	Page: D02

	
Plan It Architectural Services www.planituk.co.uk	