


SECTION A-A


SHOWN FOR LANDSCAPED AREA - FOR TANK BENEATH ROAD/PARKING BAY, TOPSOIL & SUITABLE AS-DUG MATERIAL REPLACED WITH TYPE 1 GRANULAR FILL AND ROAD CONSTRUCTION

TYPICAL ATTENUATION TANK DETAILS


REFER TO DRAINAGE LAYOUT FOR SITE SPECIFIC TANK LAYOUT/CONNECTION LOCATIONS
REFER TO SCHEDULE FOR SITE SPECIFIC DIMENSIONS

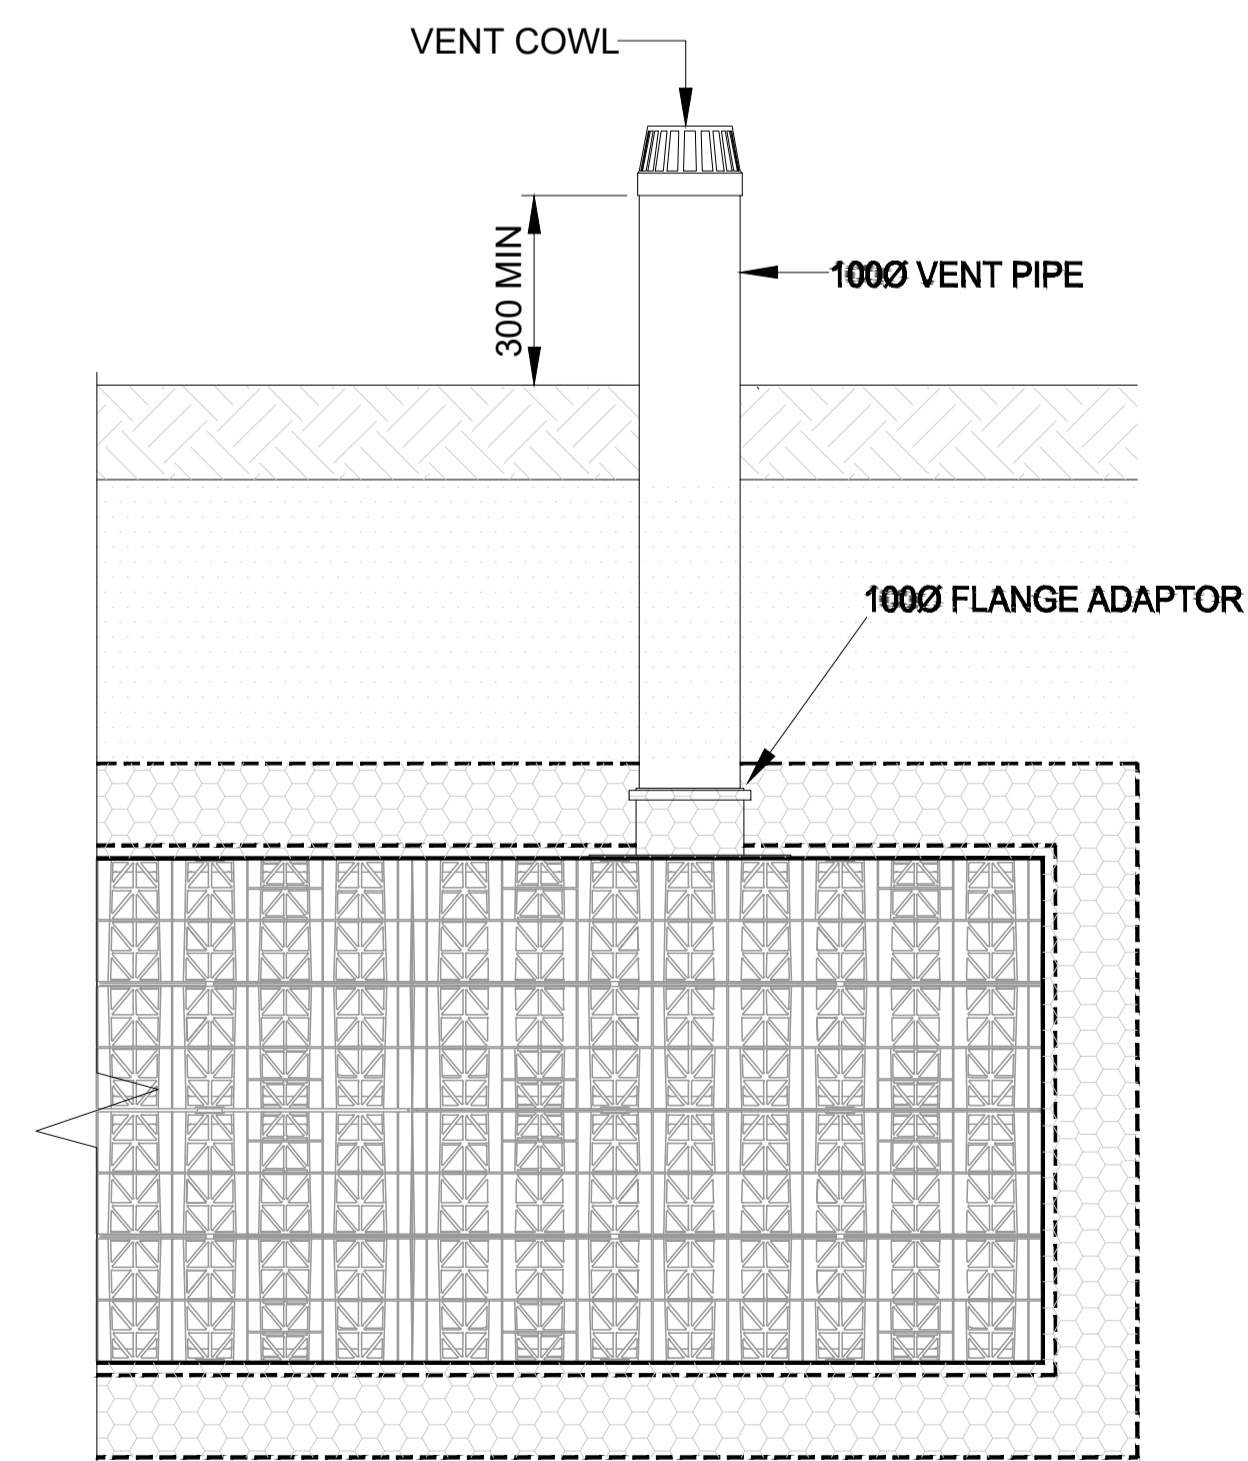

VENT PIPE DETAIL

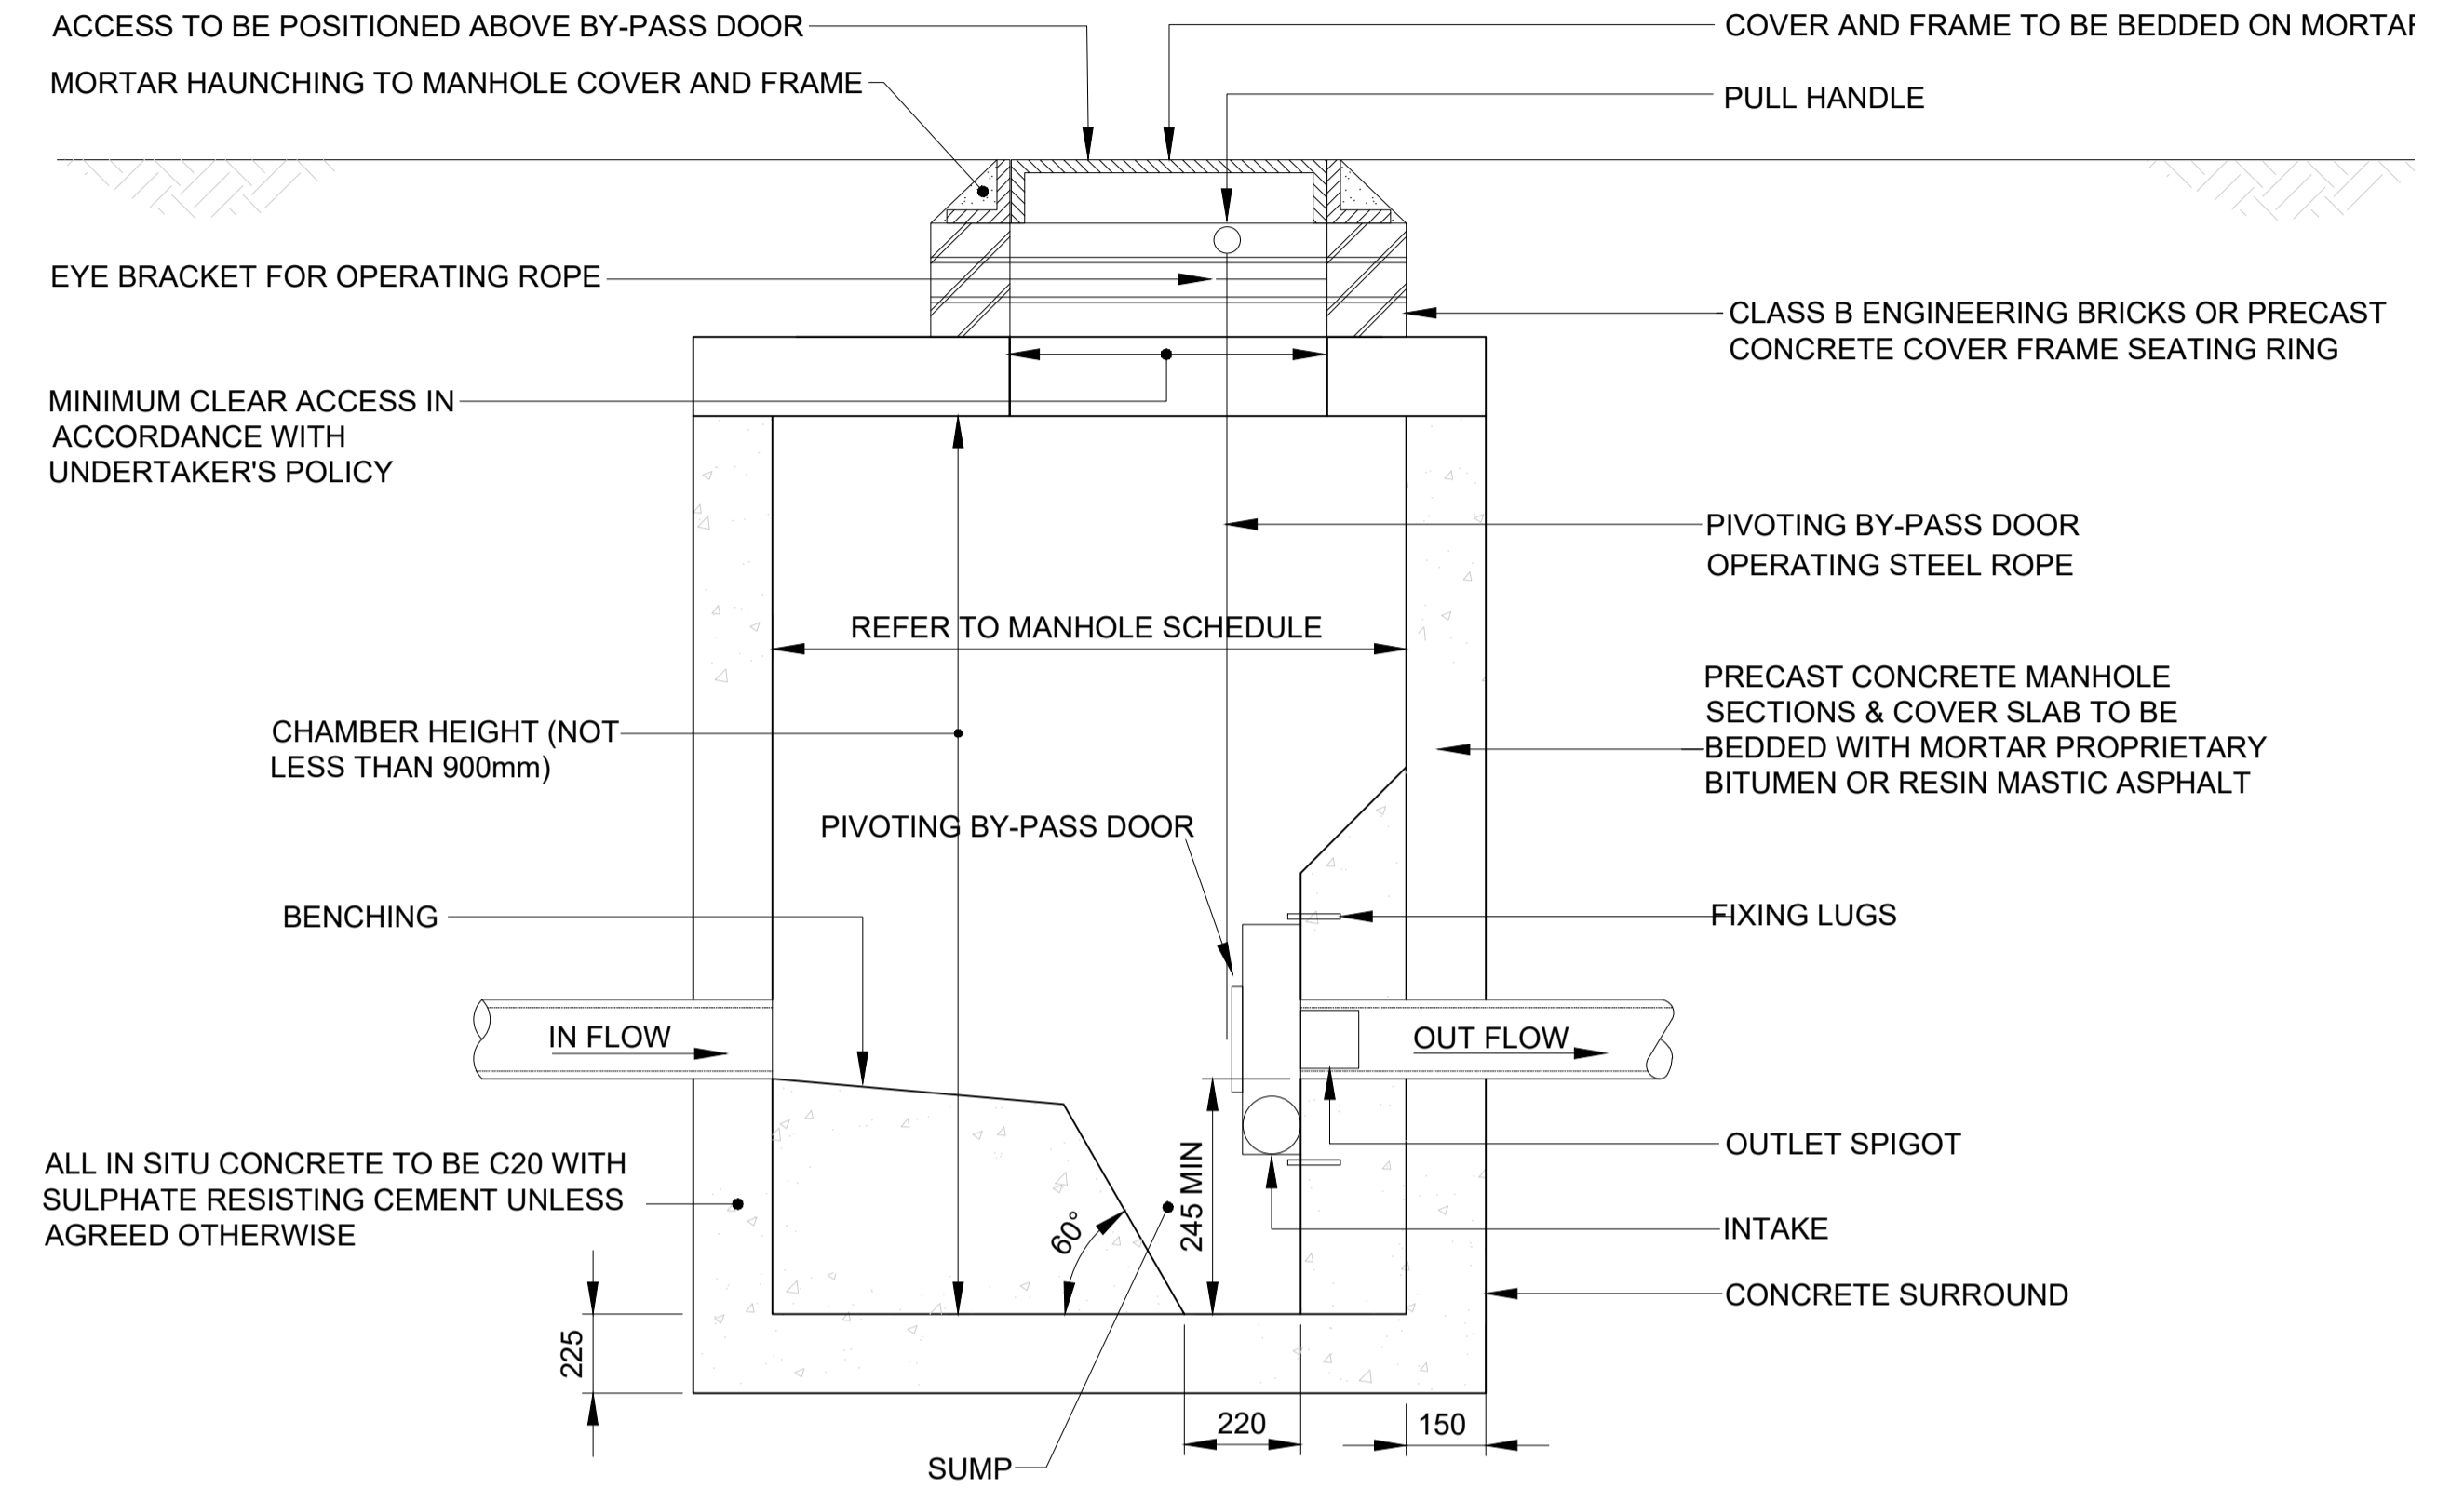

REFER TO HYDRO INTERNATIONAL DRAWINGS FOR FULL INSTALLATION DETAILS

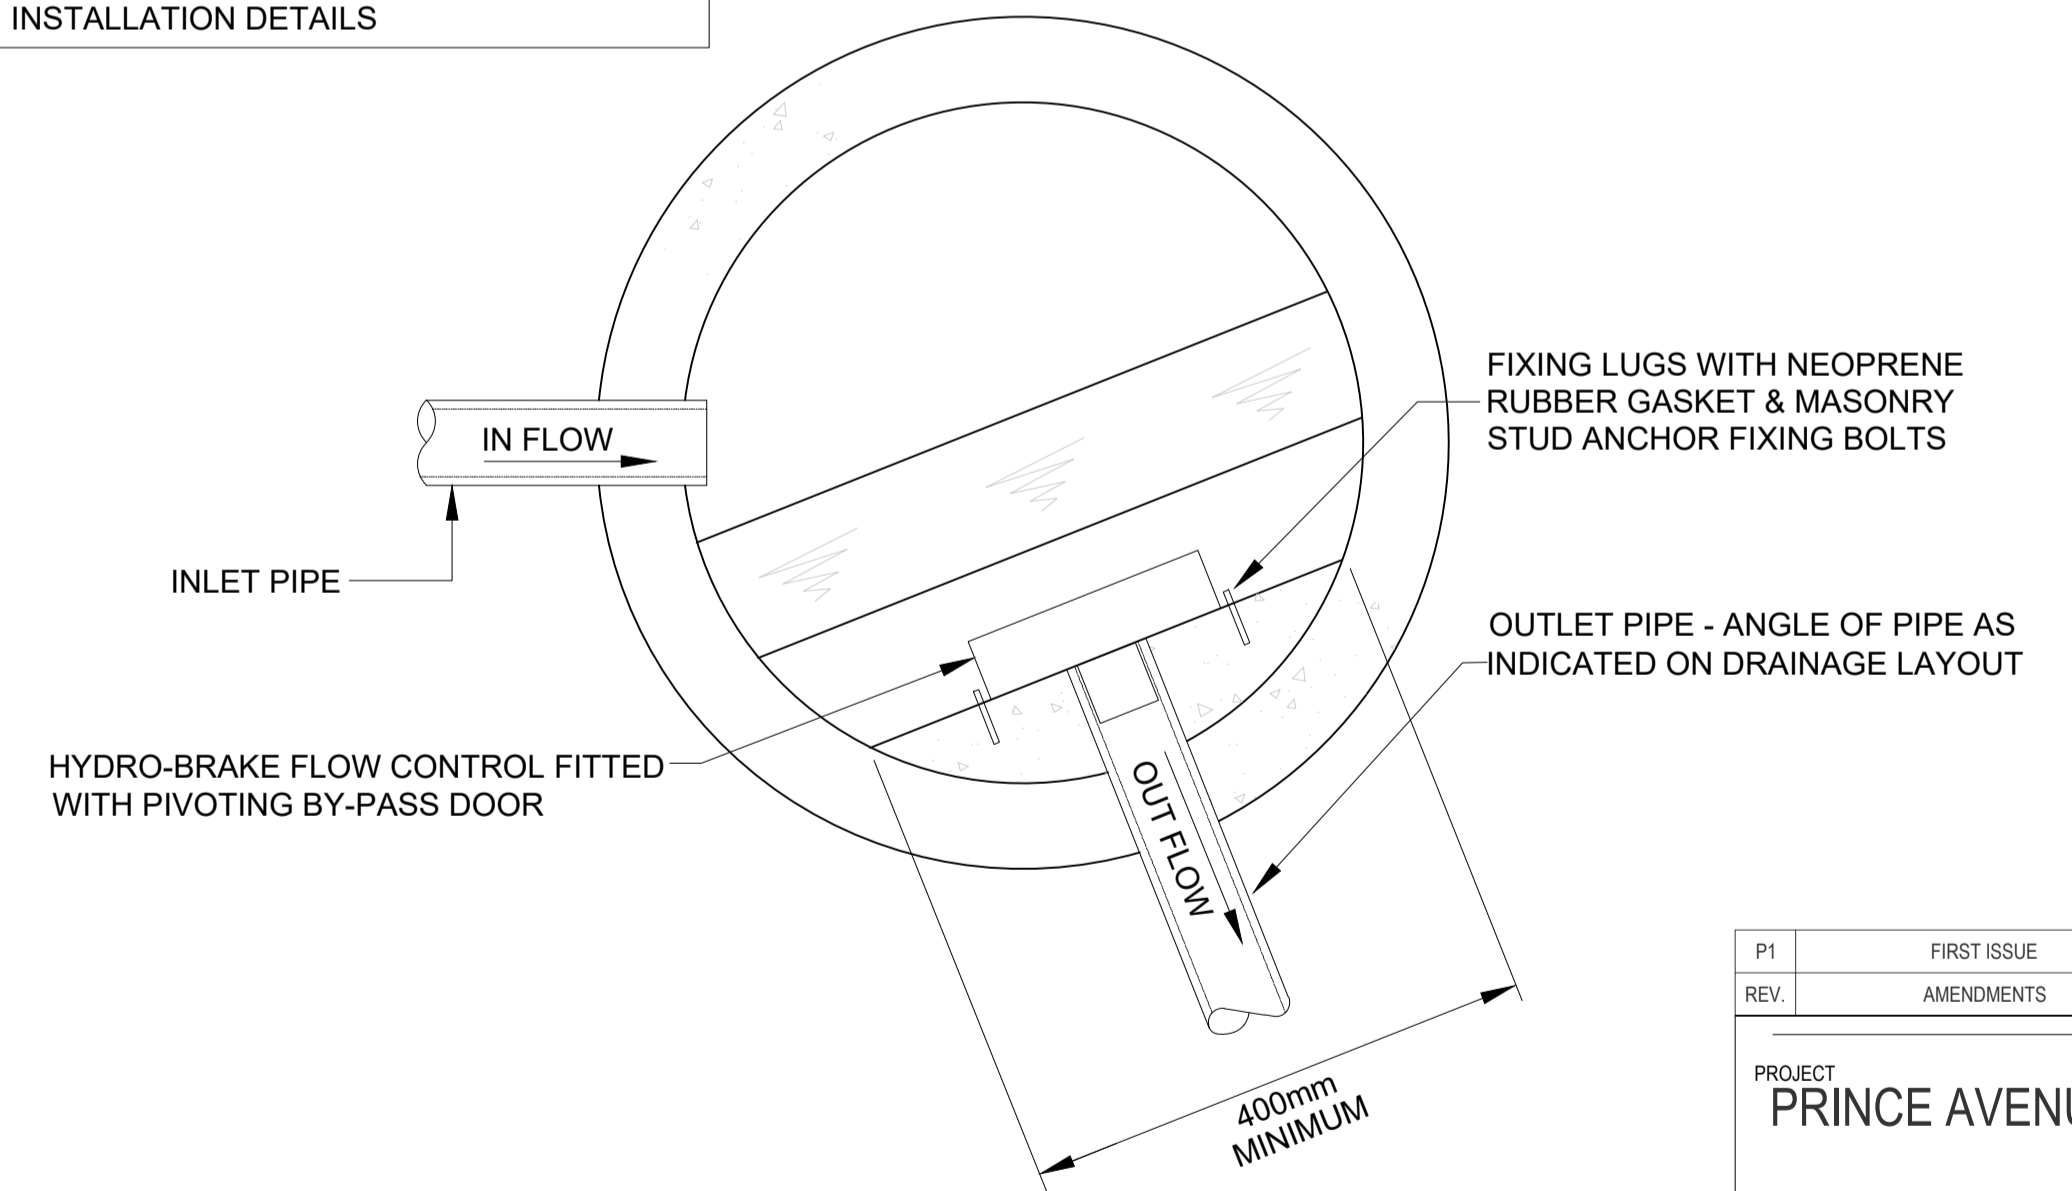

TYPICAL HYDROBRAKE CHAMBER DETAIL

PRELIMINARY ISSUE

P1	FIRST ISSUE	TS	17/03/22	AH
REV.	AMENDMENTS	BY	DATE	CHECK

PROJECT
PRINCE AVENUE PRIMARY

TITLE
MUGA PITCH DRAINAGE DETAILS

DRAWING No. SCALE VARIOUS @ A1

22011-D-800-P1