




1 Location Plan

Scale: 1:1250 A1

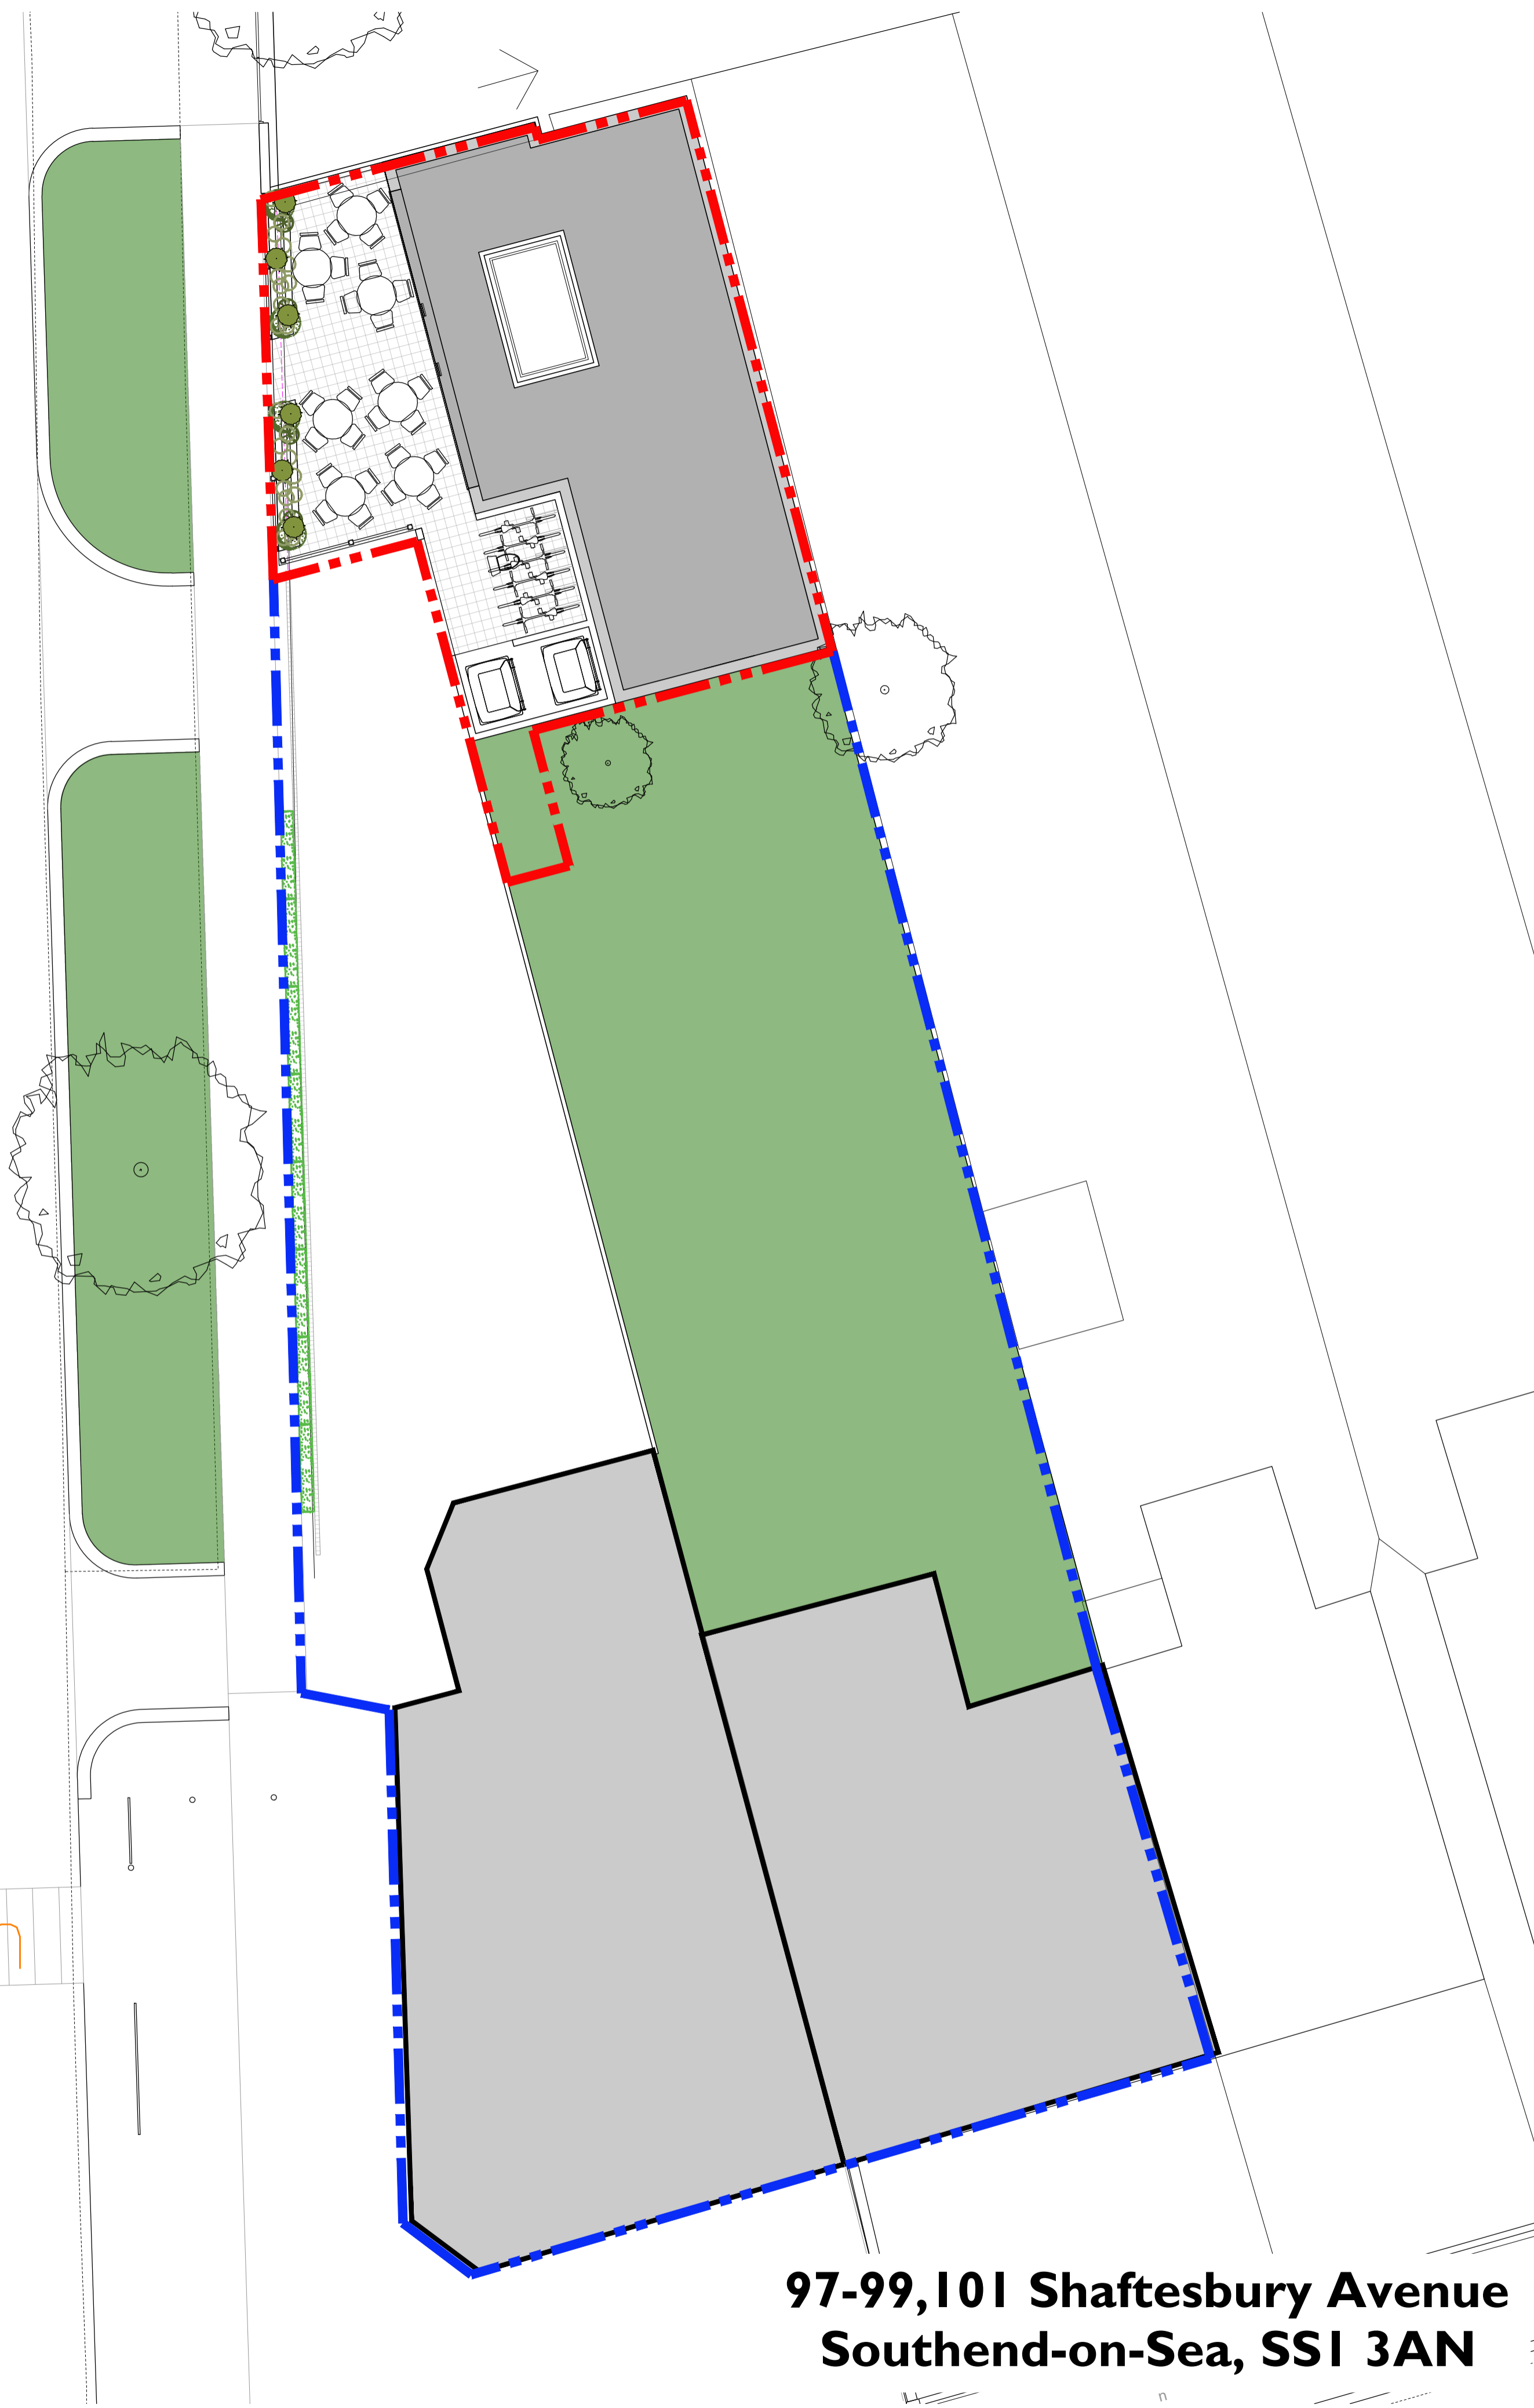

2 Site Plan

Scale: 1:100 A1

## 97-99,101 Shaftesbury Avenue Southend-on-Sea, SSI 3AN

Revision	Date	Description
A	19-07-2024	Updated existing crossover

© copyright Design Graphics Associates Ltd, all rights reserved 2024

Do not scale-off this drawing. Design Graphics Associates take no responsibility for any dimensions obtained by measuring or scaling from this drawing and no reliance may be placed on such dimensions. If no dimension is given, it is the responsibility of the recipient to ascertain the dimension specifically from the Architect or by site measurement.

The sizing of all structural and service elements must always be checked against the relevant engineers drawings. No reliance should be placed upon sizing information shown on this drawing.

Project

**97-99,101 Shaftesbury Avenue**  
Southend-on-Sea, SSI 3AN

Drawing Title  
Site and Location Plans

Drawing Number	Revision
DGA-SA-PL-ARC-SP-100	-
Scale	Revision Date
As shown	Jul 2024

Drawing Purpose  
Planning

DESIGN GRAPHICS ASSOCIATES  
Architectural Designers and Planning Consultants

26 Regents Court,  
Burnham-On-Crouch,  
Essex CM0 8PP

paul.seager@icloud.com